


Piece Mark	Quantity	Type of Material	Size of Material	Grade	Length	Finish	Notes
------------	----------	------------------	------------------	-------	--------	--------	-------

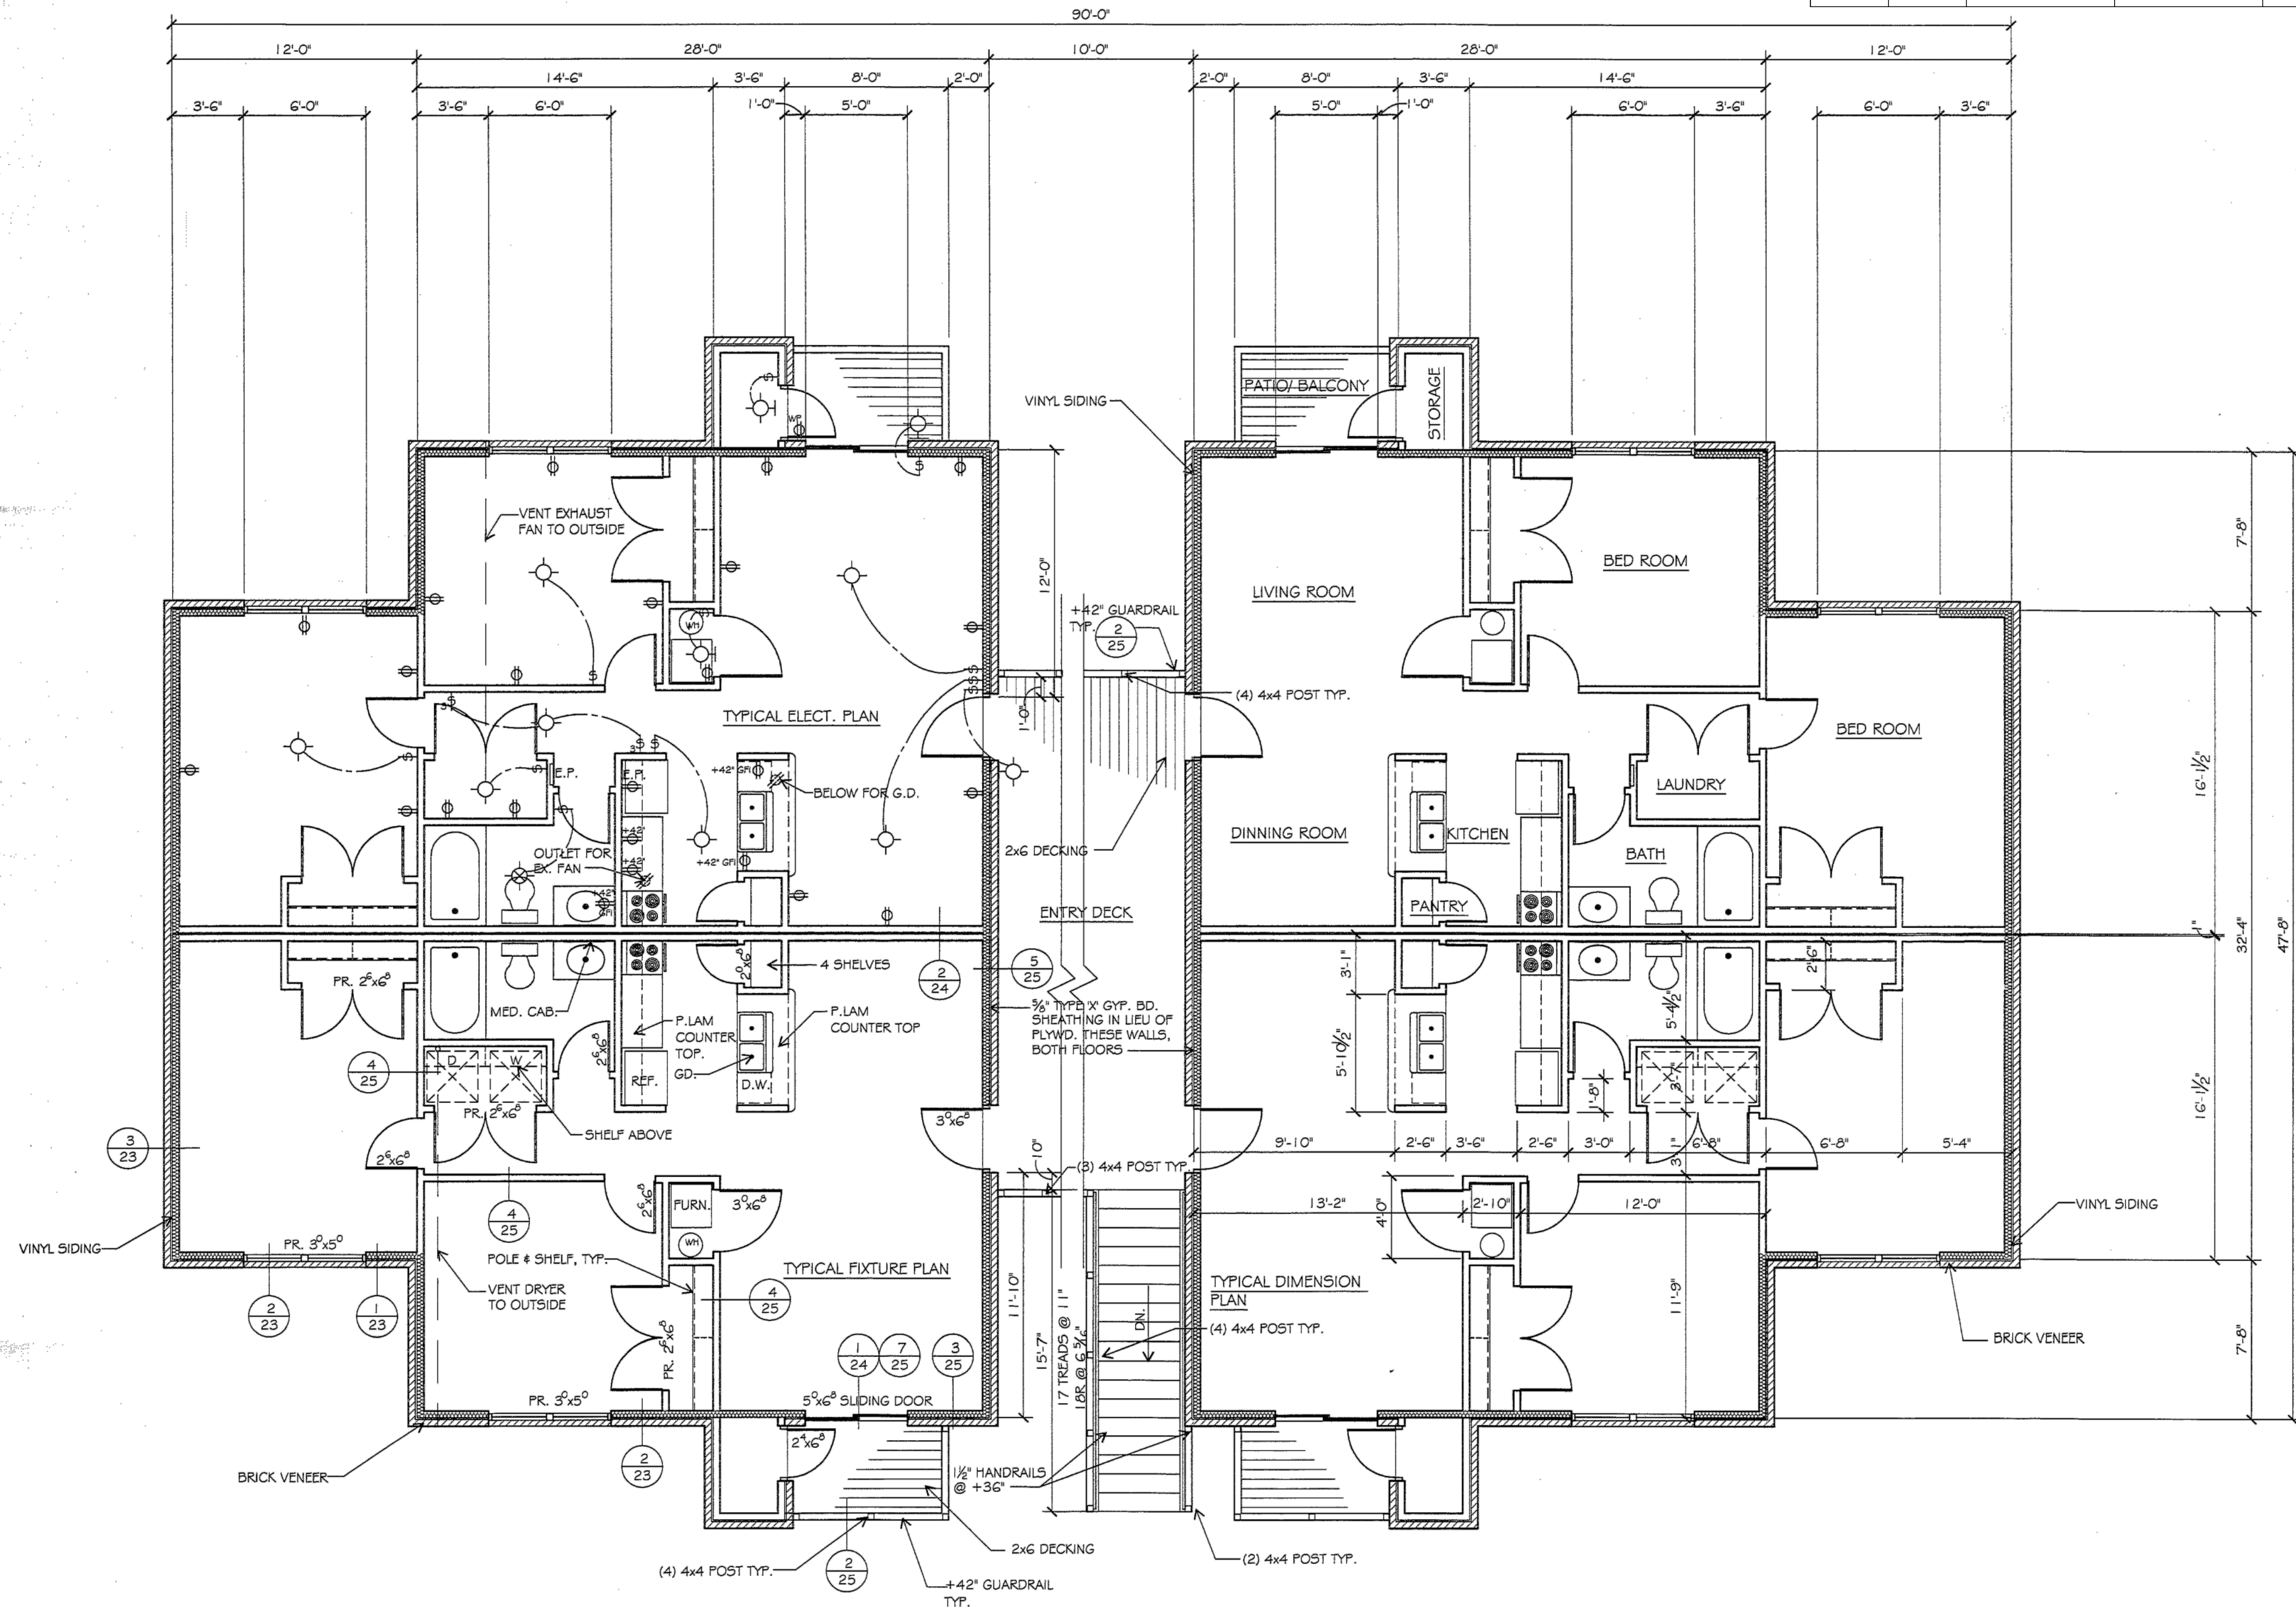

NOTE:
 1. ELECTRICAL BOXES IN FIRE RATED WALL TO BE APPROVED FOR FIRE RATED USE.
 2. RECEPTACLES IN BED ROOMS HAVE TO BE ARCH FAULT.

①
⑥ TYPICAL 2 BED ROOM FLOOR PLAN - 2ND FLOOR SHOWN, 1ST FLOOR SIM.

SCALE: 1/4" = 1'-0"

LEE
lee mechanical contractors

P.O. Box 663 Park Hills, Mo. 63601
 PHONE 573-431-6628 Fax 573-431-4560
 WWW.leemechanical.com

JOB NO.	CHK BY:	DWG BY:	DATE: 12-7-15	REV:
CUSTOMER:	SCALE: 1"=1'-0"		APR BY:	
JOB NAME: BRENLEE APARTMENTS PHASE 2	SURFACE PREP:		DRAWING NO.	
ARCH/ENG:	PRIMER:		6	
LOCATION: LEADINGTON, MD.	FINISH COAT:			